


DSNR: ZDH OPER: MDR SCALE: 1"=20'-0" 01:09:21 pm
E:\1995\99773\000\MUSE4.DWG 06-04-2001

SCALE: 1"=20'

KEYED NOTES:

- 1 E.C. SHALL USE EXTREME CAUTION WHEN CROSSING EXISTING BURIED UTILITY LINES AND PIPES. WHEN TRENCHING NEAR TREES STAY AS FAR FROM TRUNK AS POSSIBLE. (TYPICAL OF ALL CONDUIT RUNS ON THIS SHEET)
- 2 E.C. SHALL COORDINATE CONDUIT ROUTING WITH CURB INLETS AND SIGN PILES.

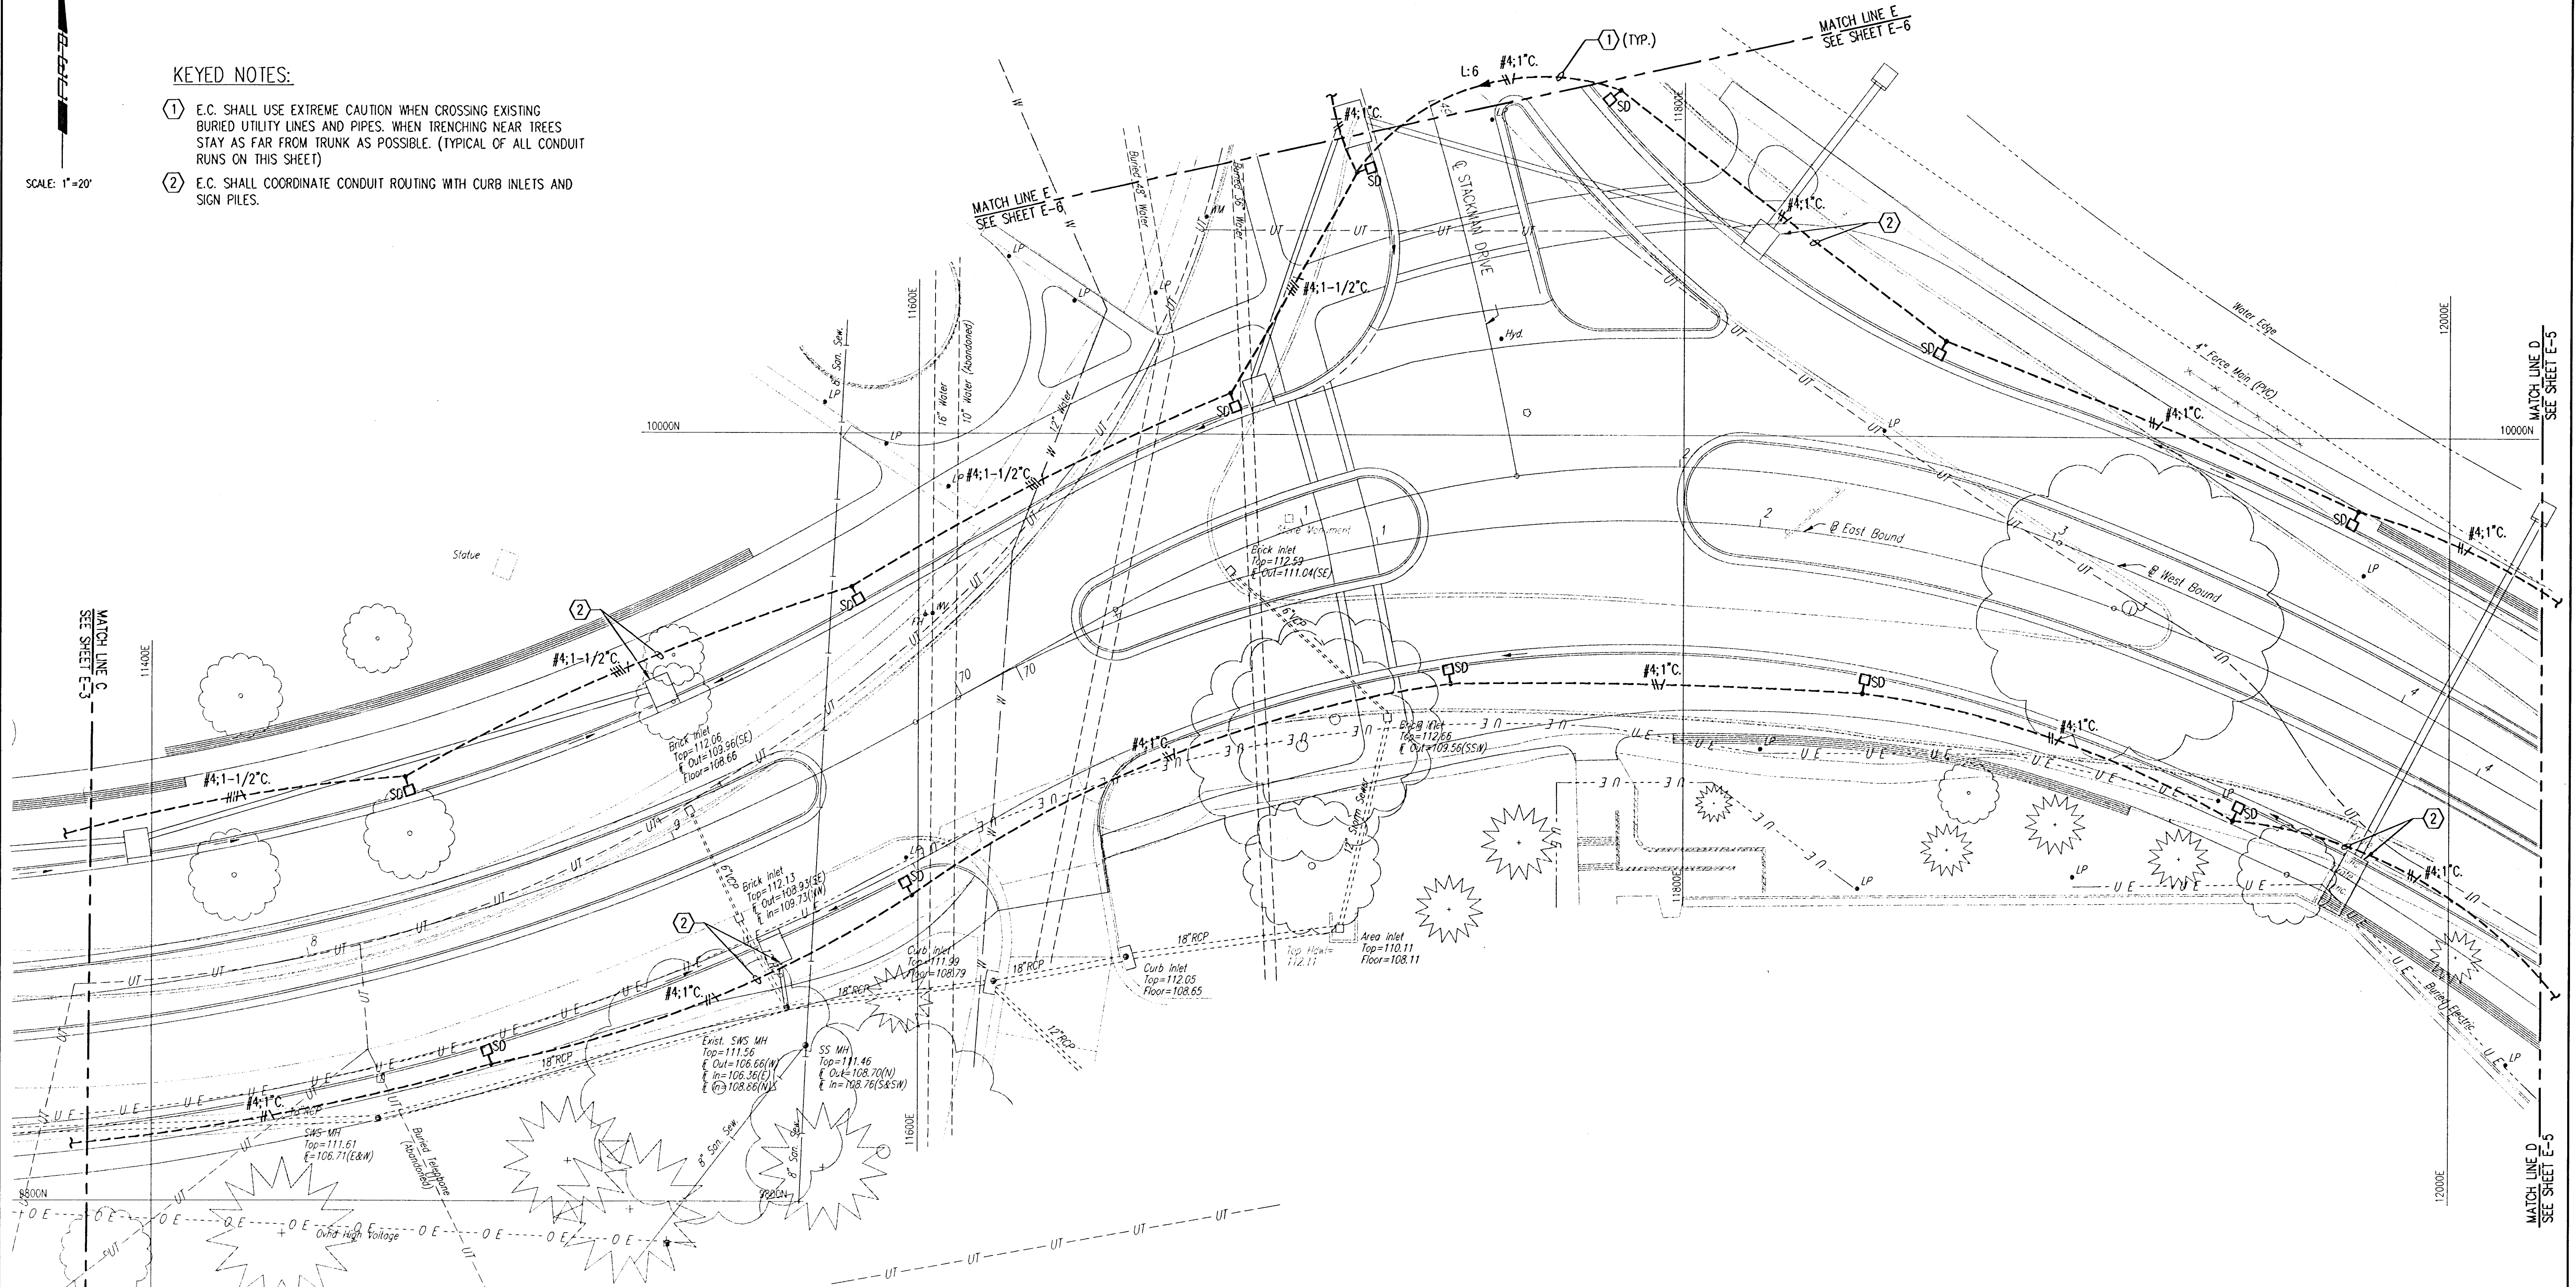

REV.	DATE	DESCRIPTION

HELLMUTH, OBATA & KASSEBAUM, INC.
DALLAS, TEXAS

PROFESSIONAL ENGINEERING
CONSULTANTS, P.A.
WICHITA, KANSAS

BRAD J. GOLDBERG
DALLAS, TEXAS

MUSEUM DISTRICT ROADWAY AND
PEDESTRIAN IMPROVEMENTS
WICHITA, KANSAS

LIGHTING PLAN

PROJECT NO.
99773-000

SCALE:
1"=20'

SHEET
E-4