


File: L:\2023\F02-2302060 - Meridian Dog Park Enhancements\Drawings\MER-C103.dwg Last Save: 4/10/2024 1:41 PM Last saved by: BThomas
Last plotted by: Gillespie, Bailey I. Plot Style: AEC_B&W.ctb Plot Scale: 1:1 Plot Date: 4/29/2024 11:39 AM Plotter used: AutoCAD PDF (General Documentation).pc3

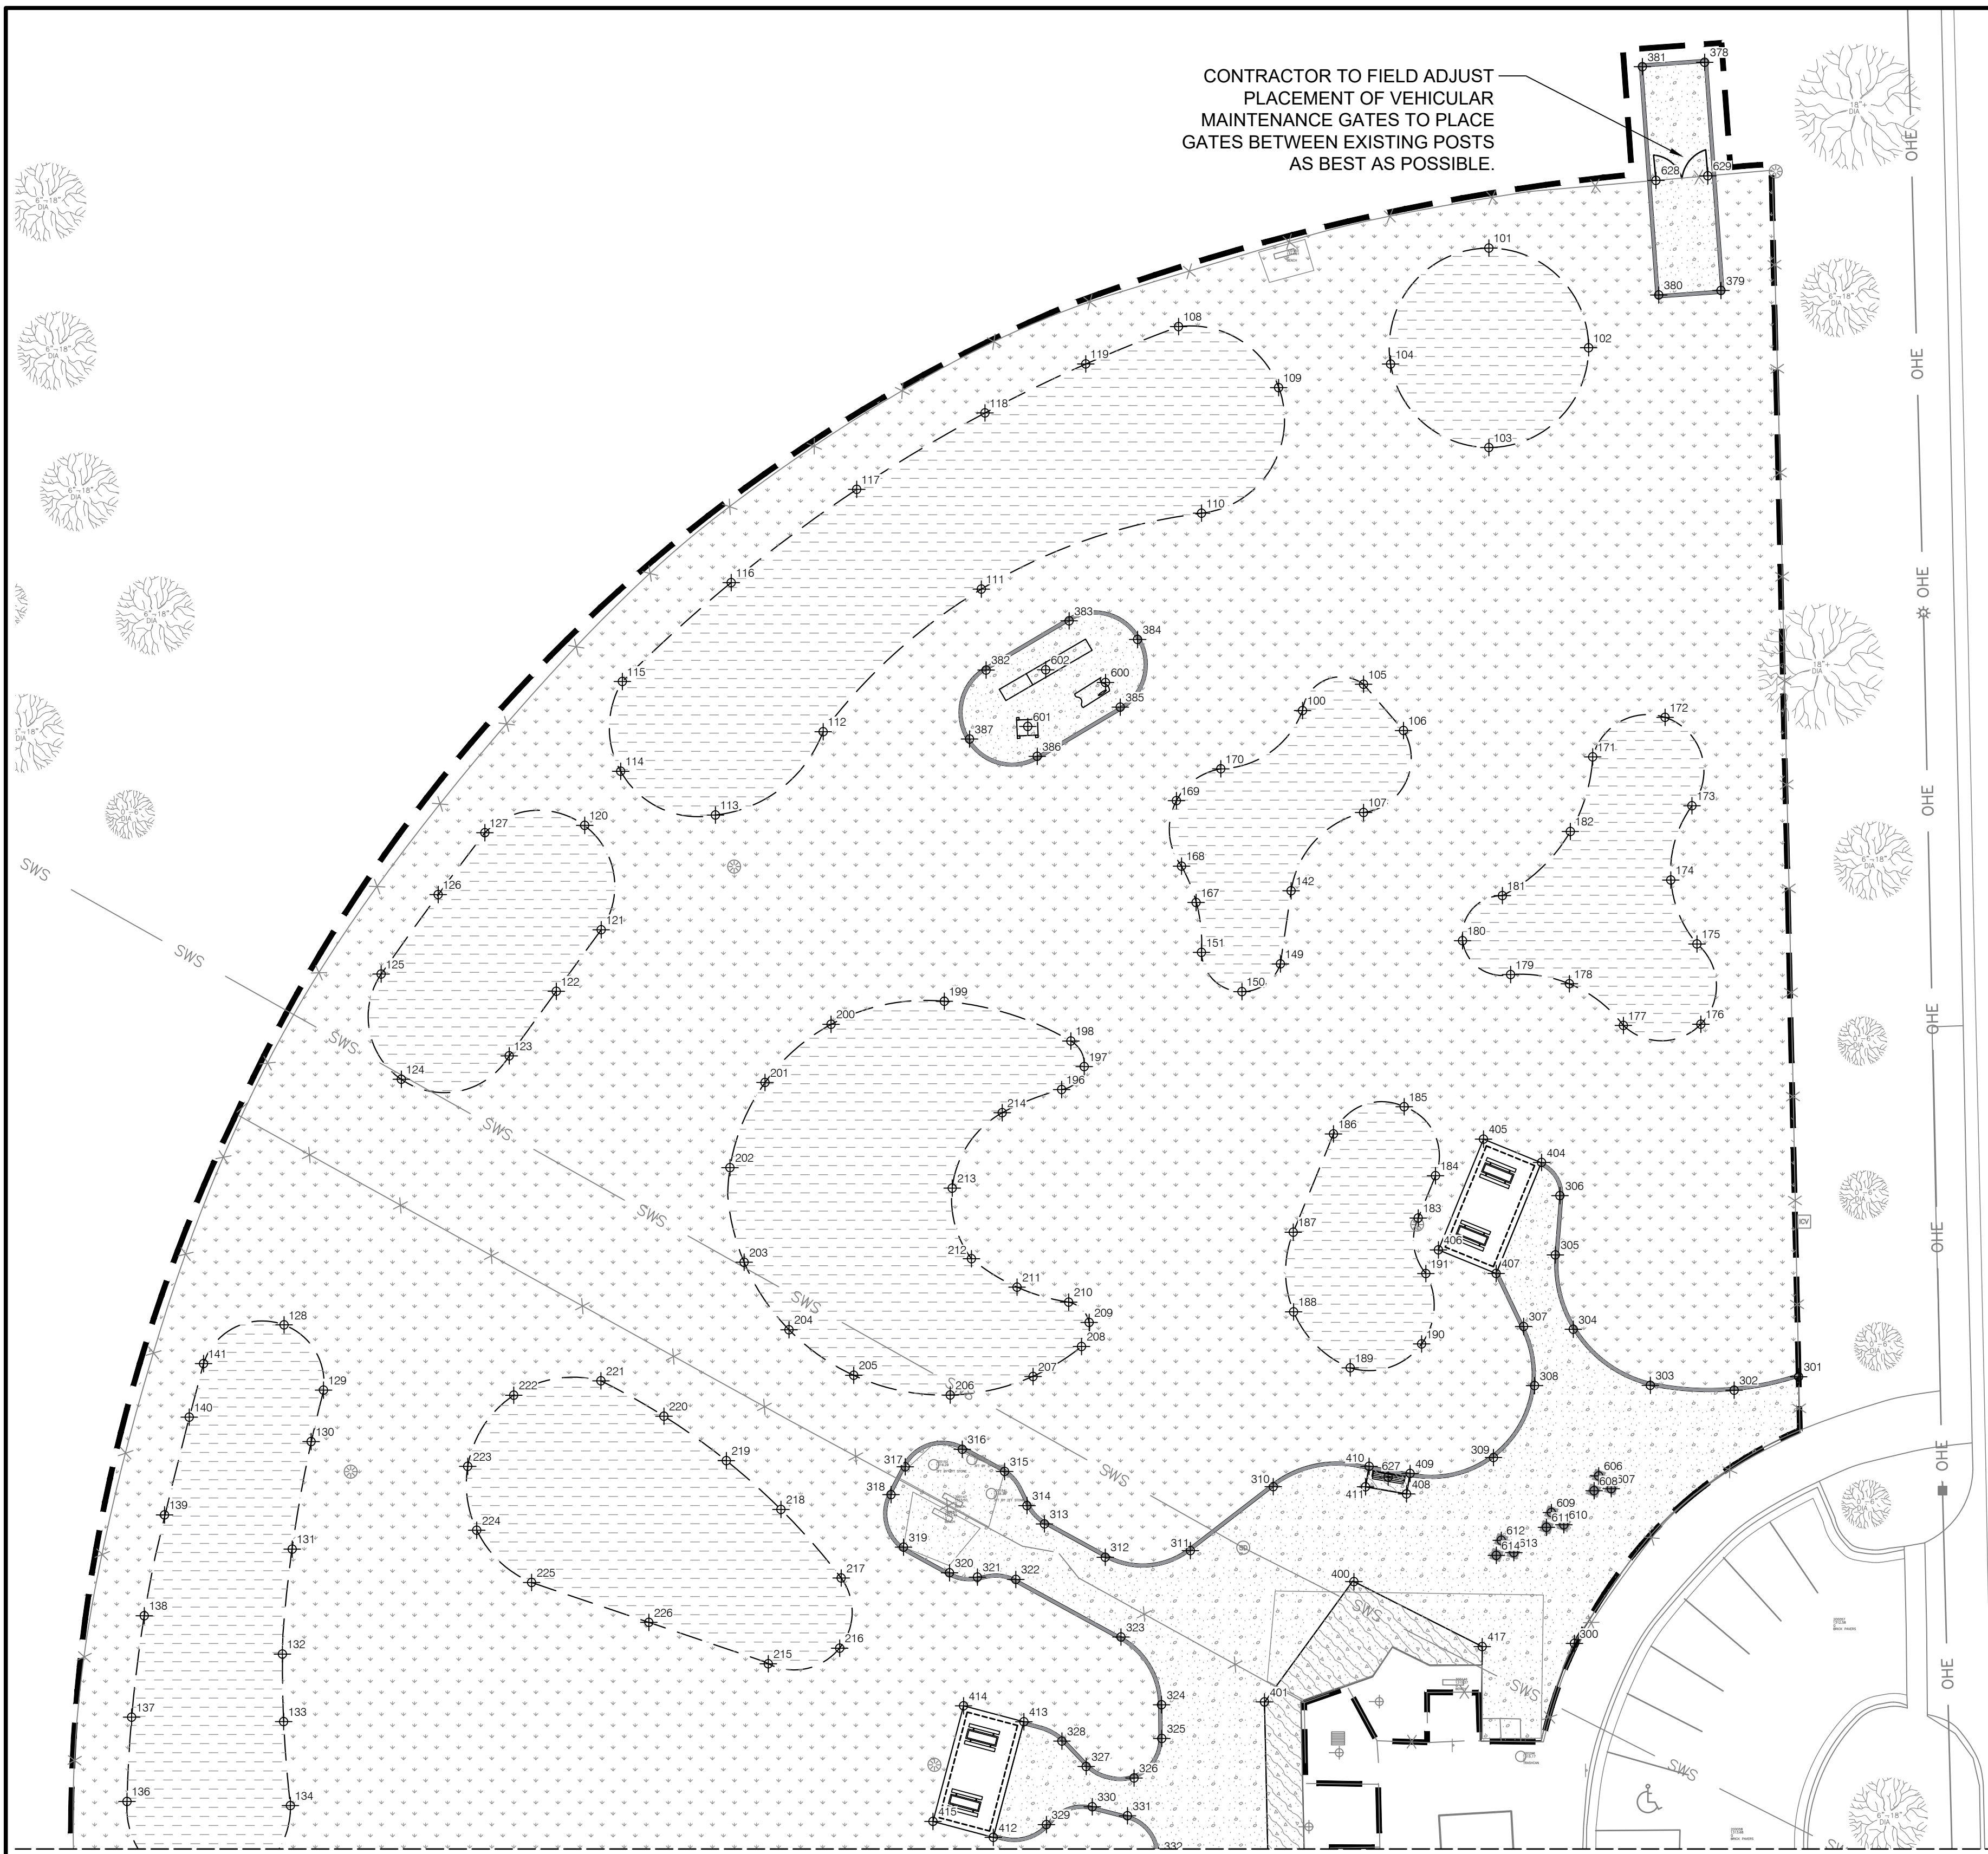

CONTRACTOR TO FIELD ADJUST
PLACEMENT OF VEHICULAR
MAINTENANCE GATES TO PLACE
GATES BETWEEN EXISTING POSTS
AS BEST AS POSSIBLE.

LEGEND

- PROPOSED SEEDED GRASS (90,560 S.F.)
REFER TO SHEET L-101 FOR NOTES AND PLANT SCHEDULE
- PROPOSED BERMS WITH SEEDED GRASS (30,355 S.F.)
REFER TO DETAIL 3/ SHEET L-502
- PROPOSED CONCRETE PAVEMENT SURFACE (1,345 S.F.)
REFER TO DETAIL 1/ SHEET C-501
-

NOTE: SEE SHEET C-105
FOR NORTHING/EASTING
POINT SCHEDULE

GARVER
© 2024 GARVER, LLC
THIS DOCUMENT, ALONG WITH THE
IDEAS AND DESIGNS CONVEYED
HEREIN, SHALL BE CONSIDERED
INSTRUMENTS OF PROFESSIONAL
SERVICE AND ARE PROPERTY OF
GARVER, LLC. ANY USE,
REPRODUCTION, OR DISTRIBUTION
OF THIS DOCUMENT, ALONG WITH
THE IDEAS AND DESIGN CONTAINED
HEREIN, IS PROHIBITED UNLESS
AUTHORIZED IN WRITING BY
GARVER, LLC OR EXPLICITLY
ALLOWED IN THE GOVERNING
PROFESSIONAL SERVICES
AGREEMENT FOR THIS WORK.

1995 Midfield Road
Wichita, KS 67209
(316) 264-8008

BRENT D. THOMAS
LICENSED
669
KANSAS
LANDSCAPE ARCHITECT
Digitally Signed 04/29/2024

REV.	DATE	DESCRIPTION	BY

CITY OF WICHITA
DEPT. OF PARK & RECREATION
WICHITA, KANSAS
2024 PARK FACILITY
ENHANCEMENTS-
K9 ROOSTER DOG PARK
ENHANCEMENTS

LAYOUT NODE PLAN
DOG PARK NORTH


JOB NO.: 2302060
DATE: MAY 2024
DESIGNED BY: BDT
DRAWN BY: HG

BAR IS ONE INCH ON
ORIGINAL DRAWING
0 1"
IF NOT ONE INCH ON THIS SHEET,
ADJUST SCALES ACCORDINGLY.

DRAWING NUMBER
C-103

SHEET
NUMBER

A LAYOUT NODE PLAN- NORTH
SCALE: 1" = 20'

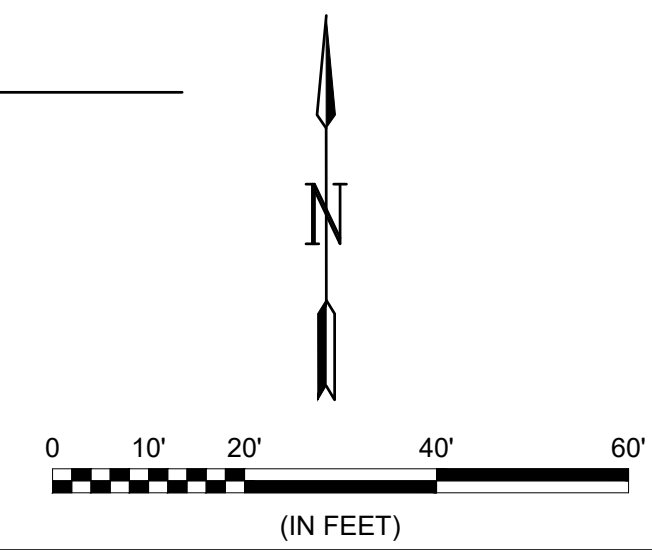

MATCH LINE-SEE SHEET C-104