



1 DUCTBANK SECTION
NO SCALE

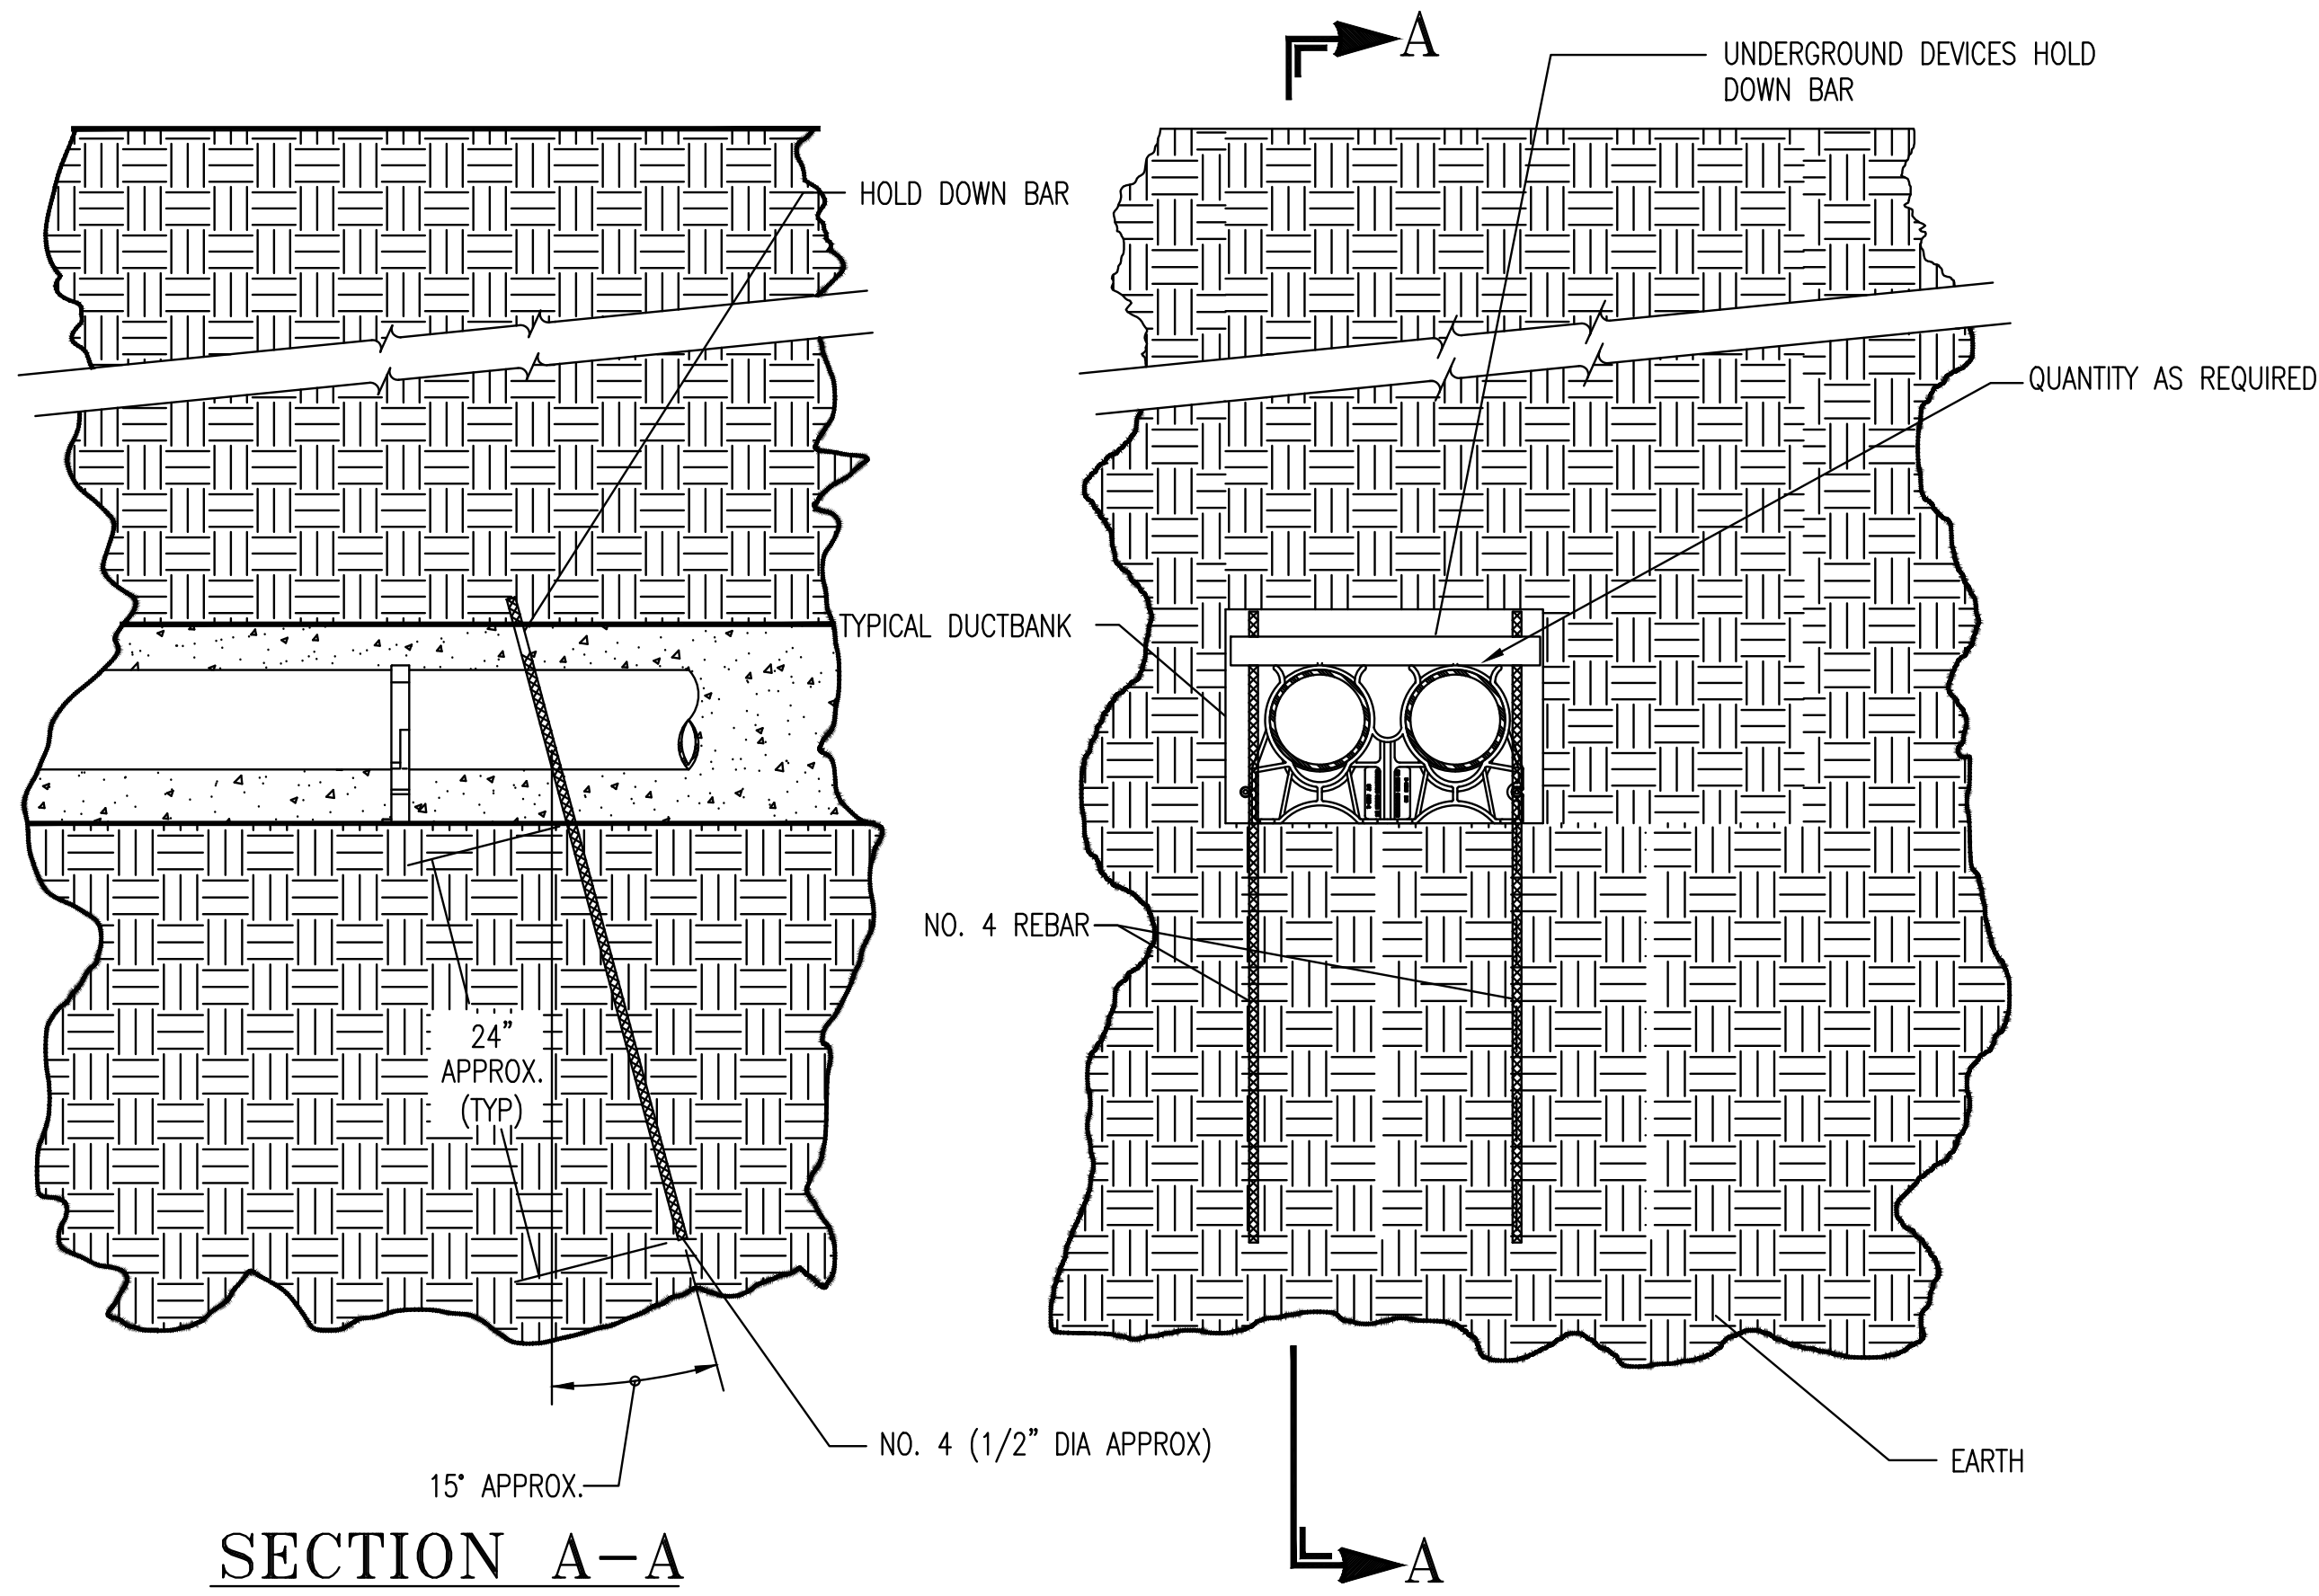



2 SECTION A-A
NO SCALE

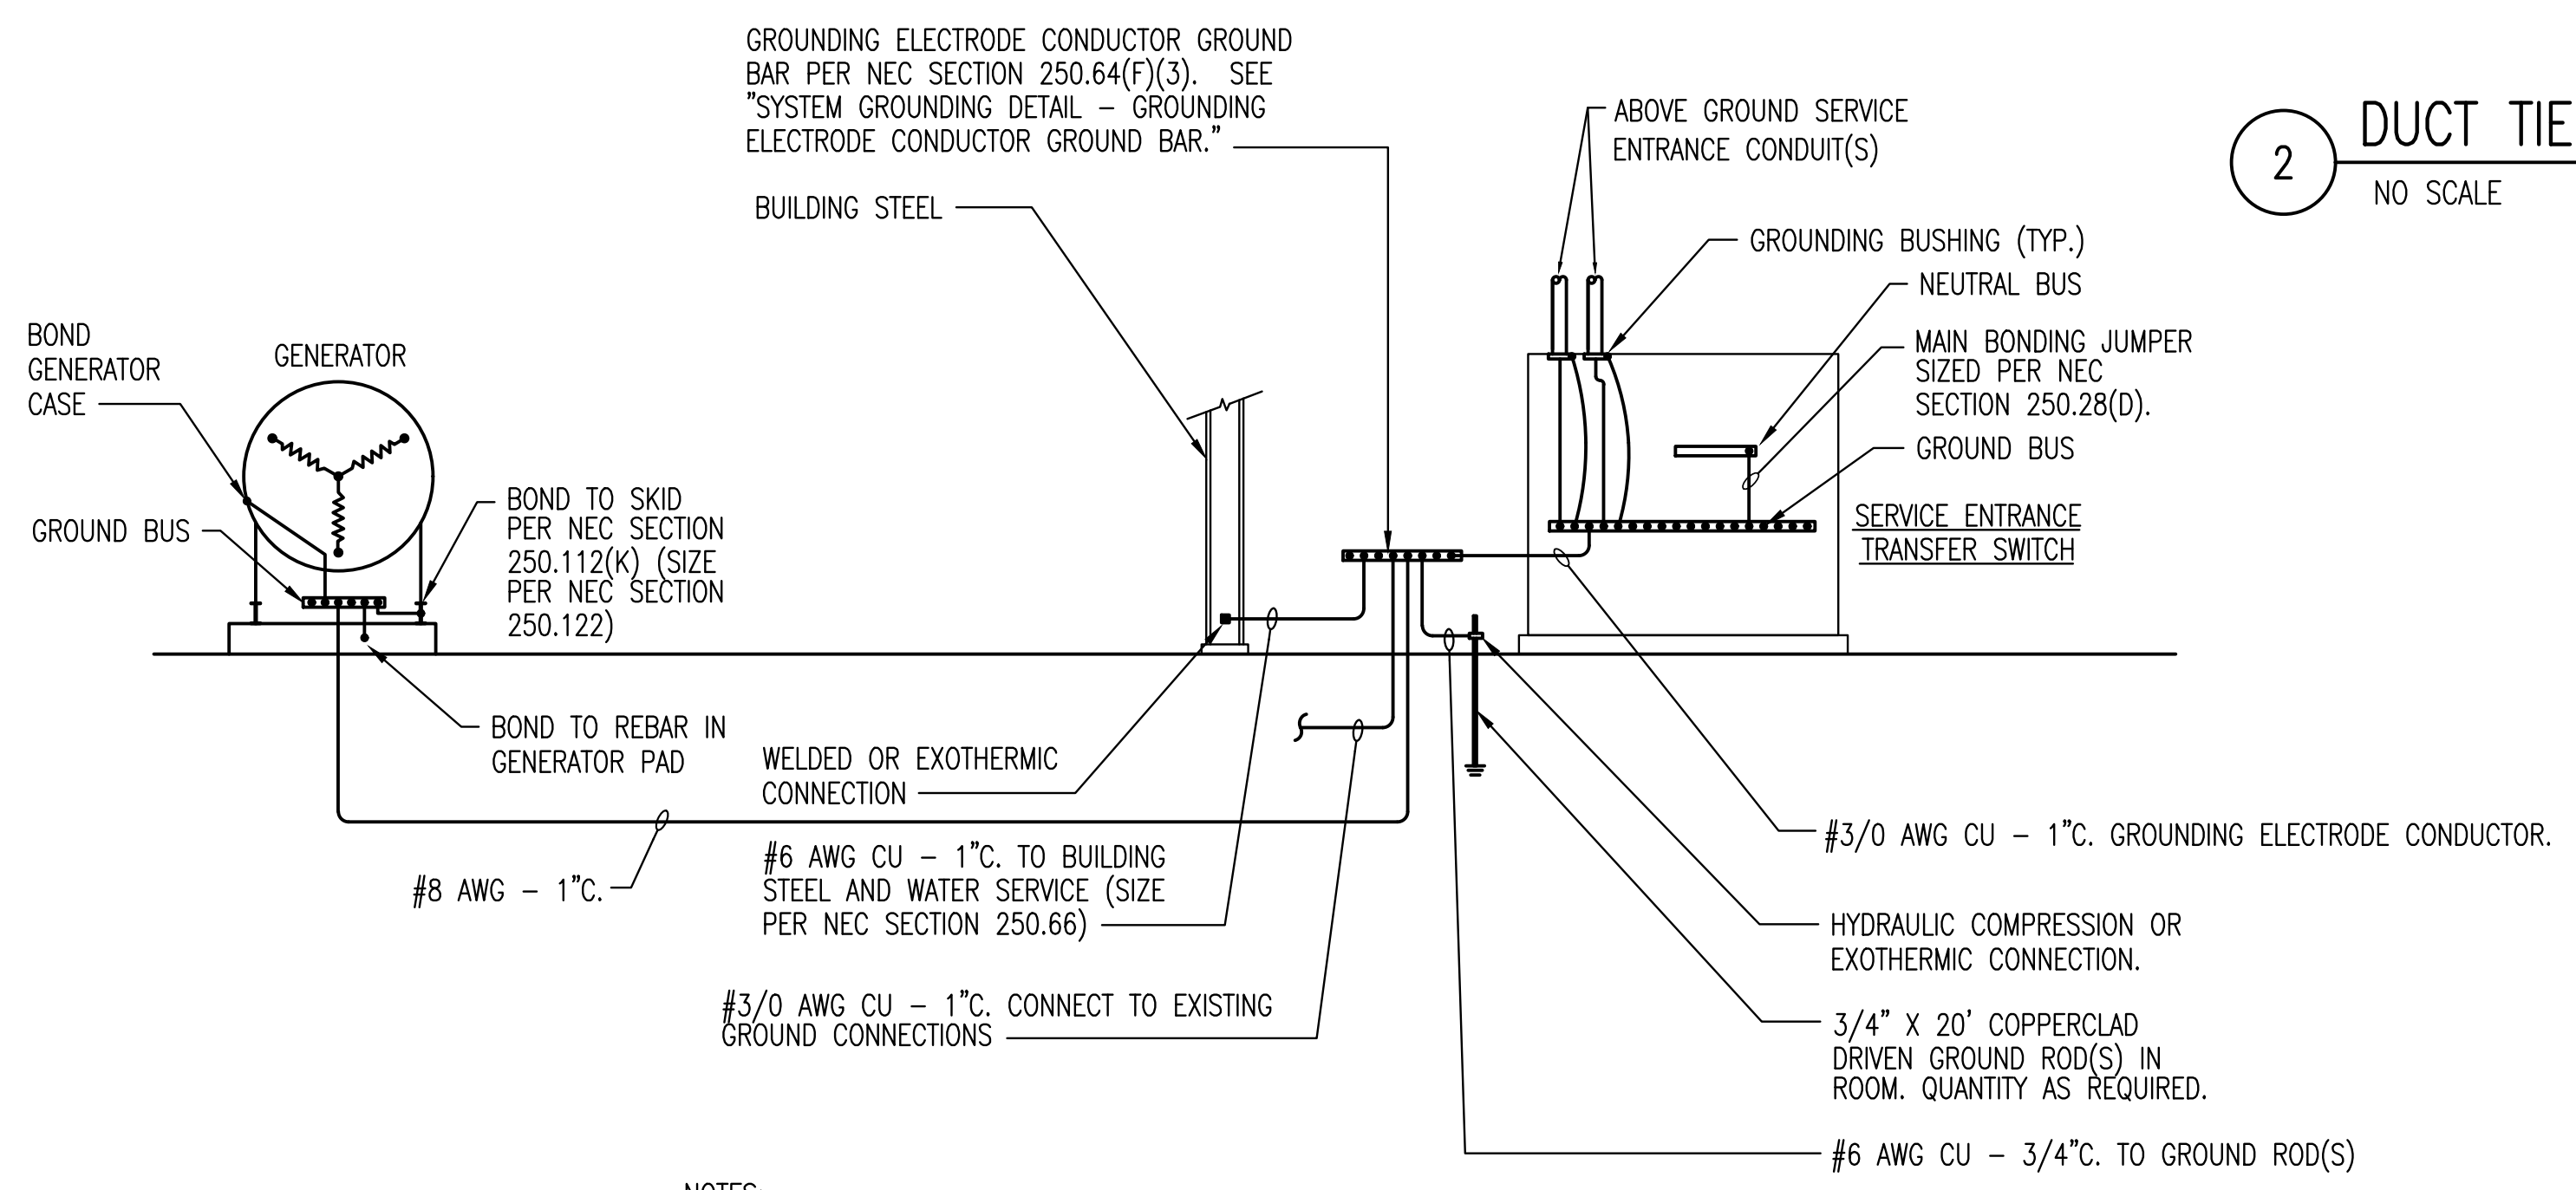

3 SYSTEM GROUNDING DETAIL - PANEL WITH 3-POLE ATS
NO SCALE

DESIGNER NOTE: SIZE GROUNDING ELECTRODE CONDUCTORS AND BONDING JUMPERS TO BUILDING STEEL AND WATER SERVICE PER NEC SECTION 250.66

U:\WICHITA-CIVIL\2022\1217043008\ELECTRICAL\DRAWINGS\E502 ELECTRICAL DETAILS.DWG
 PLOTTED 3/9/2022 1:55:07 PM BY BEN CHAPLIN
 SAVED 3/9/2022 1:47:11 PM BY BEN CHAPLIN

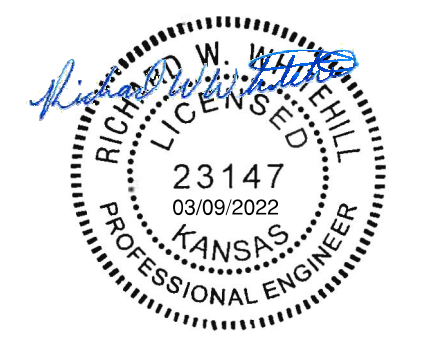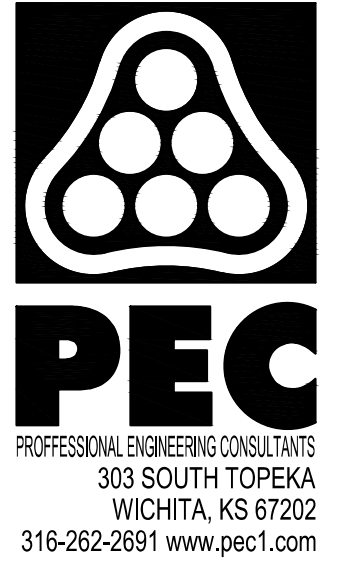

SANITARY SEWER IMPROVEMENTS
LIFT STATION NO. 23
 AT
W. 37TH STREET N AND PORTER AVE.
 GARY JANZEN, P.E. - CITY ENGINEER
 CITY OF WICHITA PROJECT NO. 468-2020-019218 S0015

Issue:	

JOB NO.	217043-008
DATE	MARCH 2022
PM	RWW
DESIGNED BY	DCG
DRAWN BY	BAC
CHECKED BY	RWW

ELECTRICAL DETAILS

E502