


SANITARY SEWER IMPROVEMENTS COWSKIN FORCE MAIN AND LIFT STATION 60 IMPROVEMENTS

CITY OF WICHITA, KANSAS
PAUL GUNZELMAN, P.E. - CITY ENGINEER

CITY OF WICHITA ENGINEERING PROJECT NO. 468-2022-040654
ORG CODE 53202120, MUNIS NO. S0021

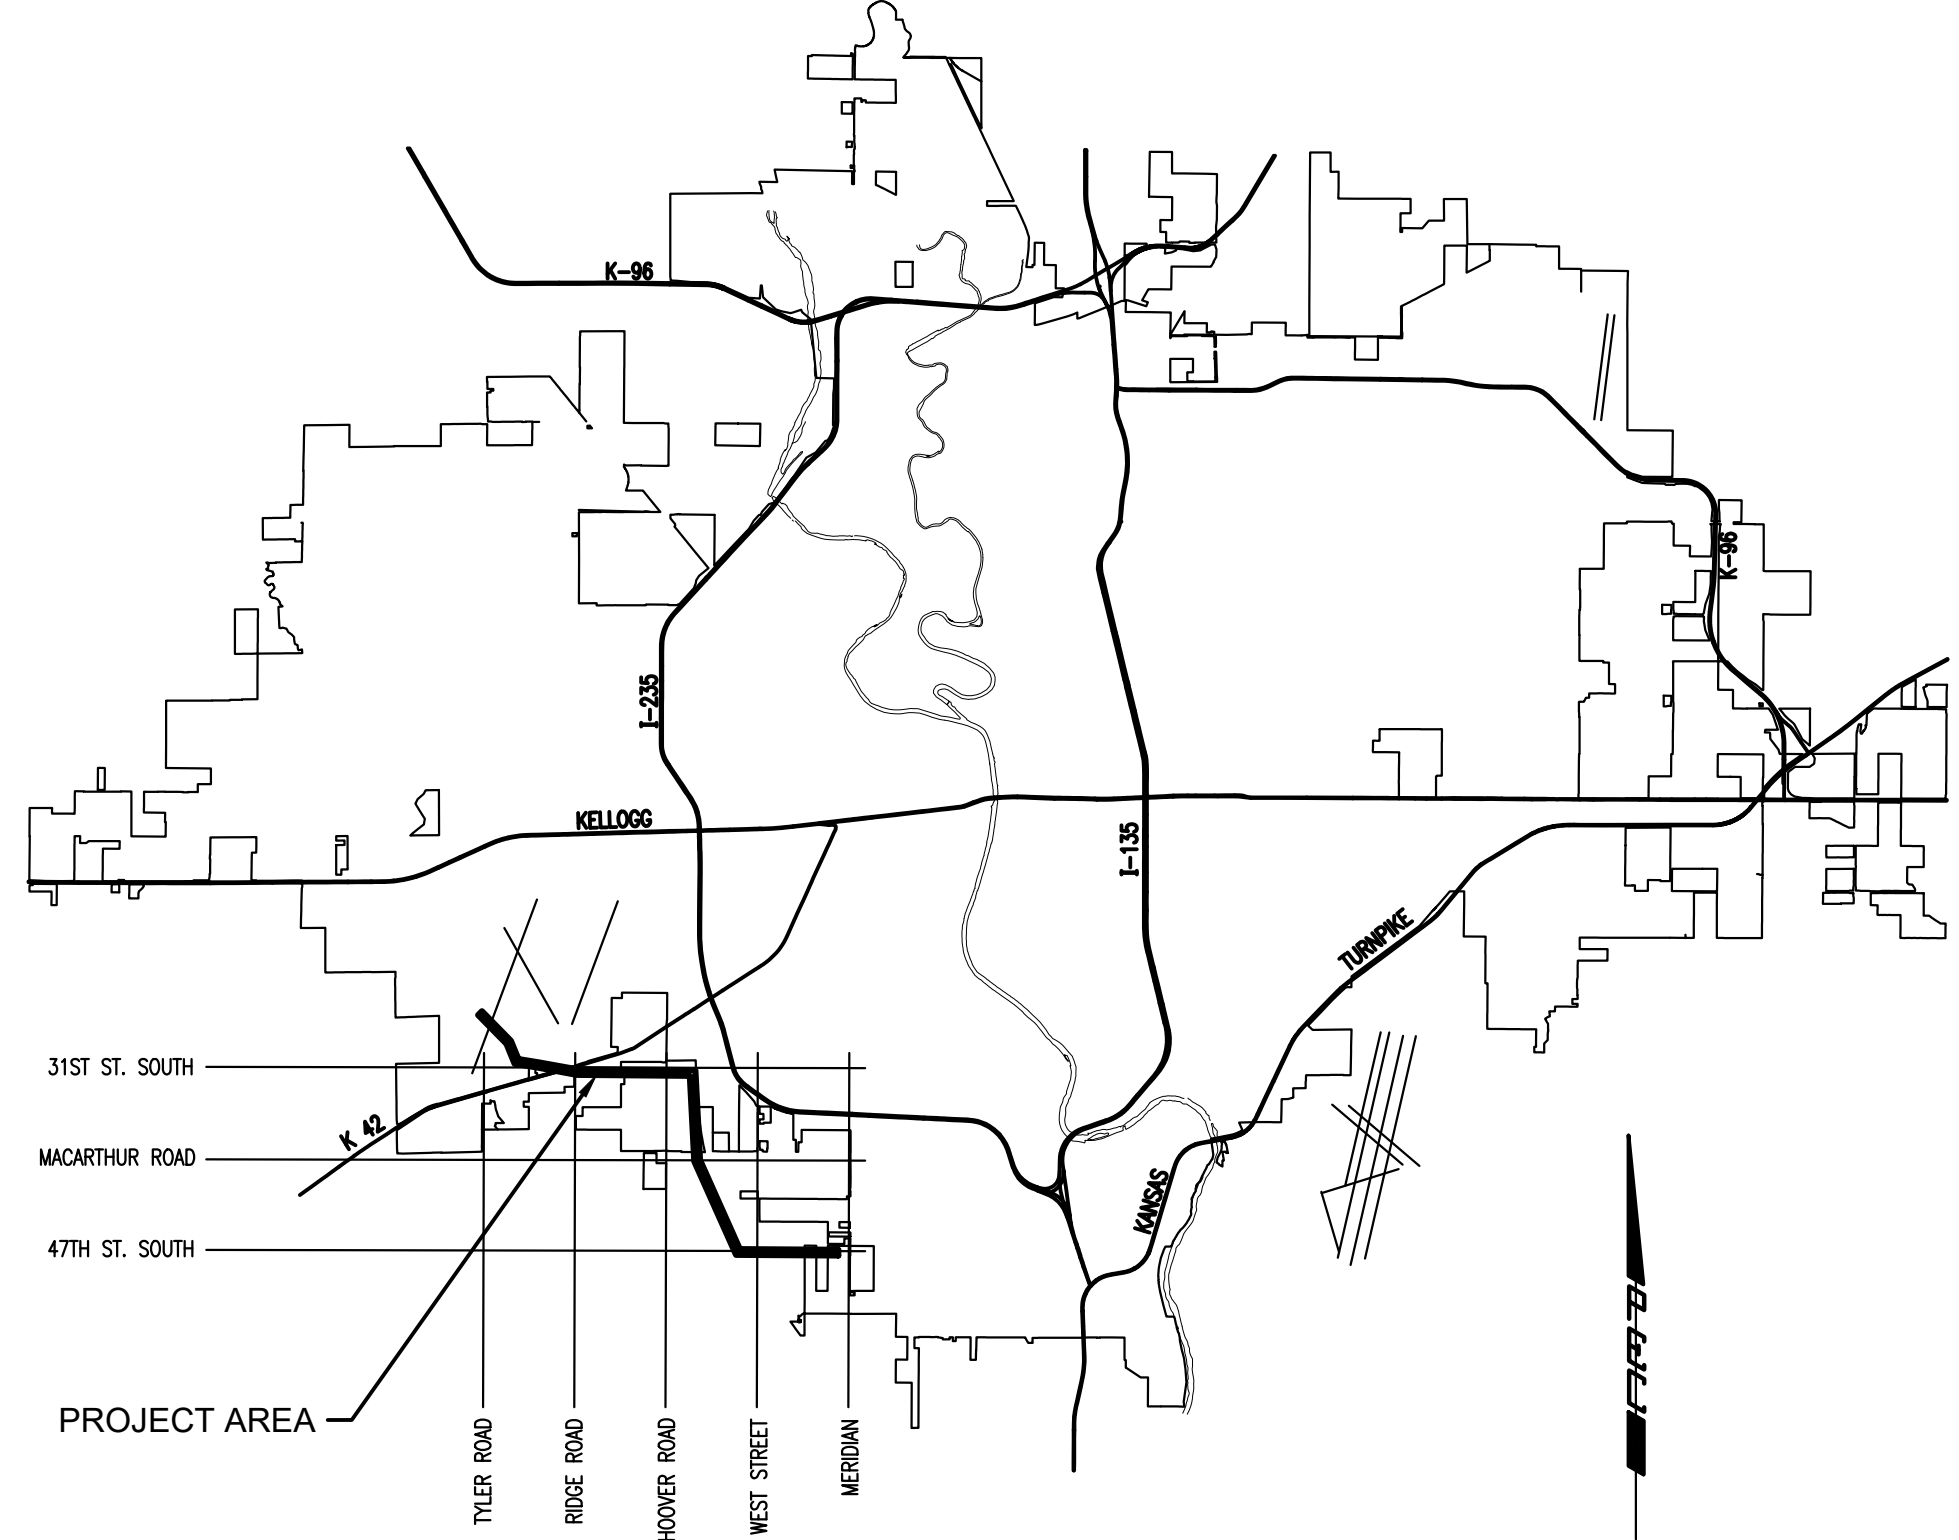

LOCATION MAP

INDEX OF SHEETS

SHEET NUMBER	SHEET TITLE
C-001	TITLE SHEET
C-002	GENERAL NOTES
CU101	EXISTING AIR RELEASE IMPROVEMENTS
CU102	LIFT STATION 60 FORCE MAIN CONNECTION KEY MAP
CU103	FORCE MAIN RECONNECTION
CU501	EXISTING AIR VALVE REPLACEMENT DETAIL
CU502	LIFT STATION 60 REHAB DETAIL
CU503	MISCELLANEOUS WATER DETAILS
CU504	TRACER WIRE AND WARNING SIGN
CU505	PRECAST SANITARY SEWER MANHOLE
CU506	MANHOLE FRAME AND COVER
CU601	EROSION CONTROL DETAILS
CU602	EROSION CONTROL DETAILS
CU603	EROSION CONTROL DETAILS
CU604	EROSION CONTROL DETAILS
E-001	ELECTRICAL LEAD SHEET
E-002	ELECTRICAL CONTROLS SCHEMATIC
E-101	ELECTRICAL DEMOLITION PLAN
E-301	ELECTRICAL POWER PLAN
E-501	ELECTRICAL DETAILS
E-502	ELECTRICAL DETAILS
E-601	ELECTRICAL SCHEDULES

SAVED 12/14/2023 2:12:18 PM BY CATHY LINK
 PLOTTED 12/14/2023 2:12:26 PM BY CATHY LINK
 U:\WICHITA-CIVIL\2021\210602\001\MUNI\DRAWINGS\AIR VALVE REPLACEMENTS\210602-001-C-001.DWG



**SANITARY SEWER IMPROVEMENTS
COWSKIN FORCE MAIN
AND LIFT STATION 60
IMPROVEMENTS**
 PAUL GUNZELMAN, P.E. - INTERIM CITY ENGINEER
 CITY OF WICHITA PROJECT NO. 468-2022-040654

Issue:		
JOB NO.	35-210602-001-042	
DATE	DECEMBER 2023	
PM	TBK	
DESIGNED BY	KJW	
DRAWN BY	CSL	
CHECKED BY	RWG	

TITLE SHEET

C-001