

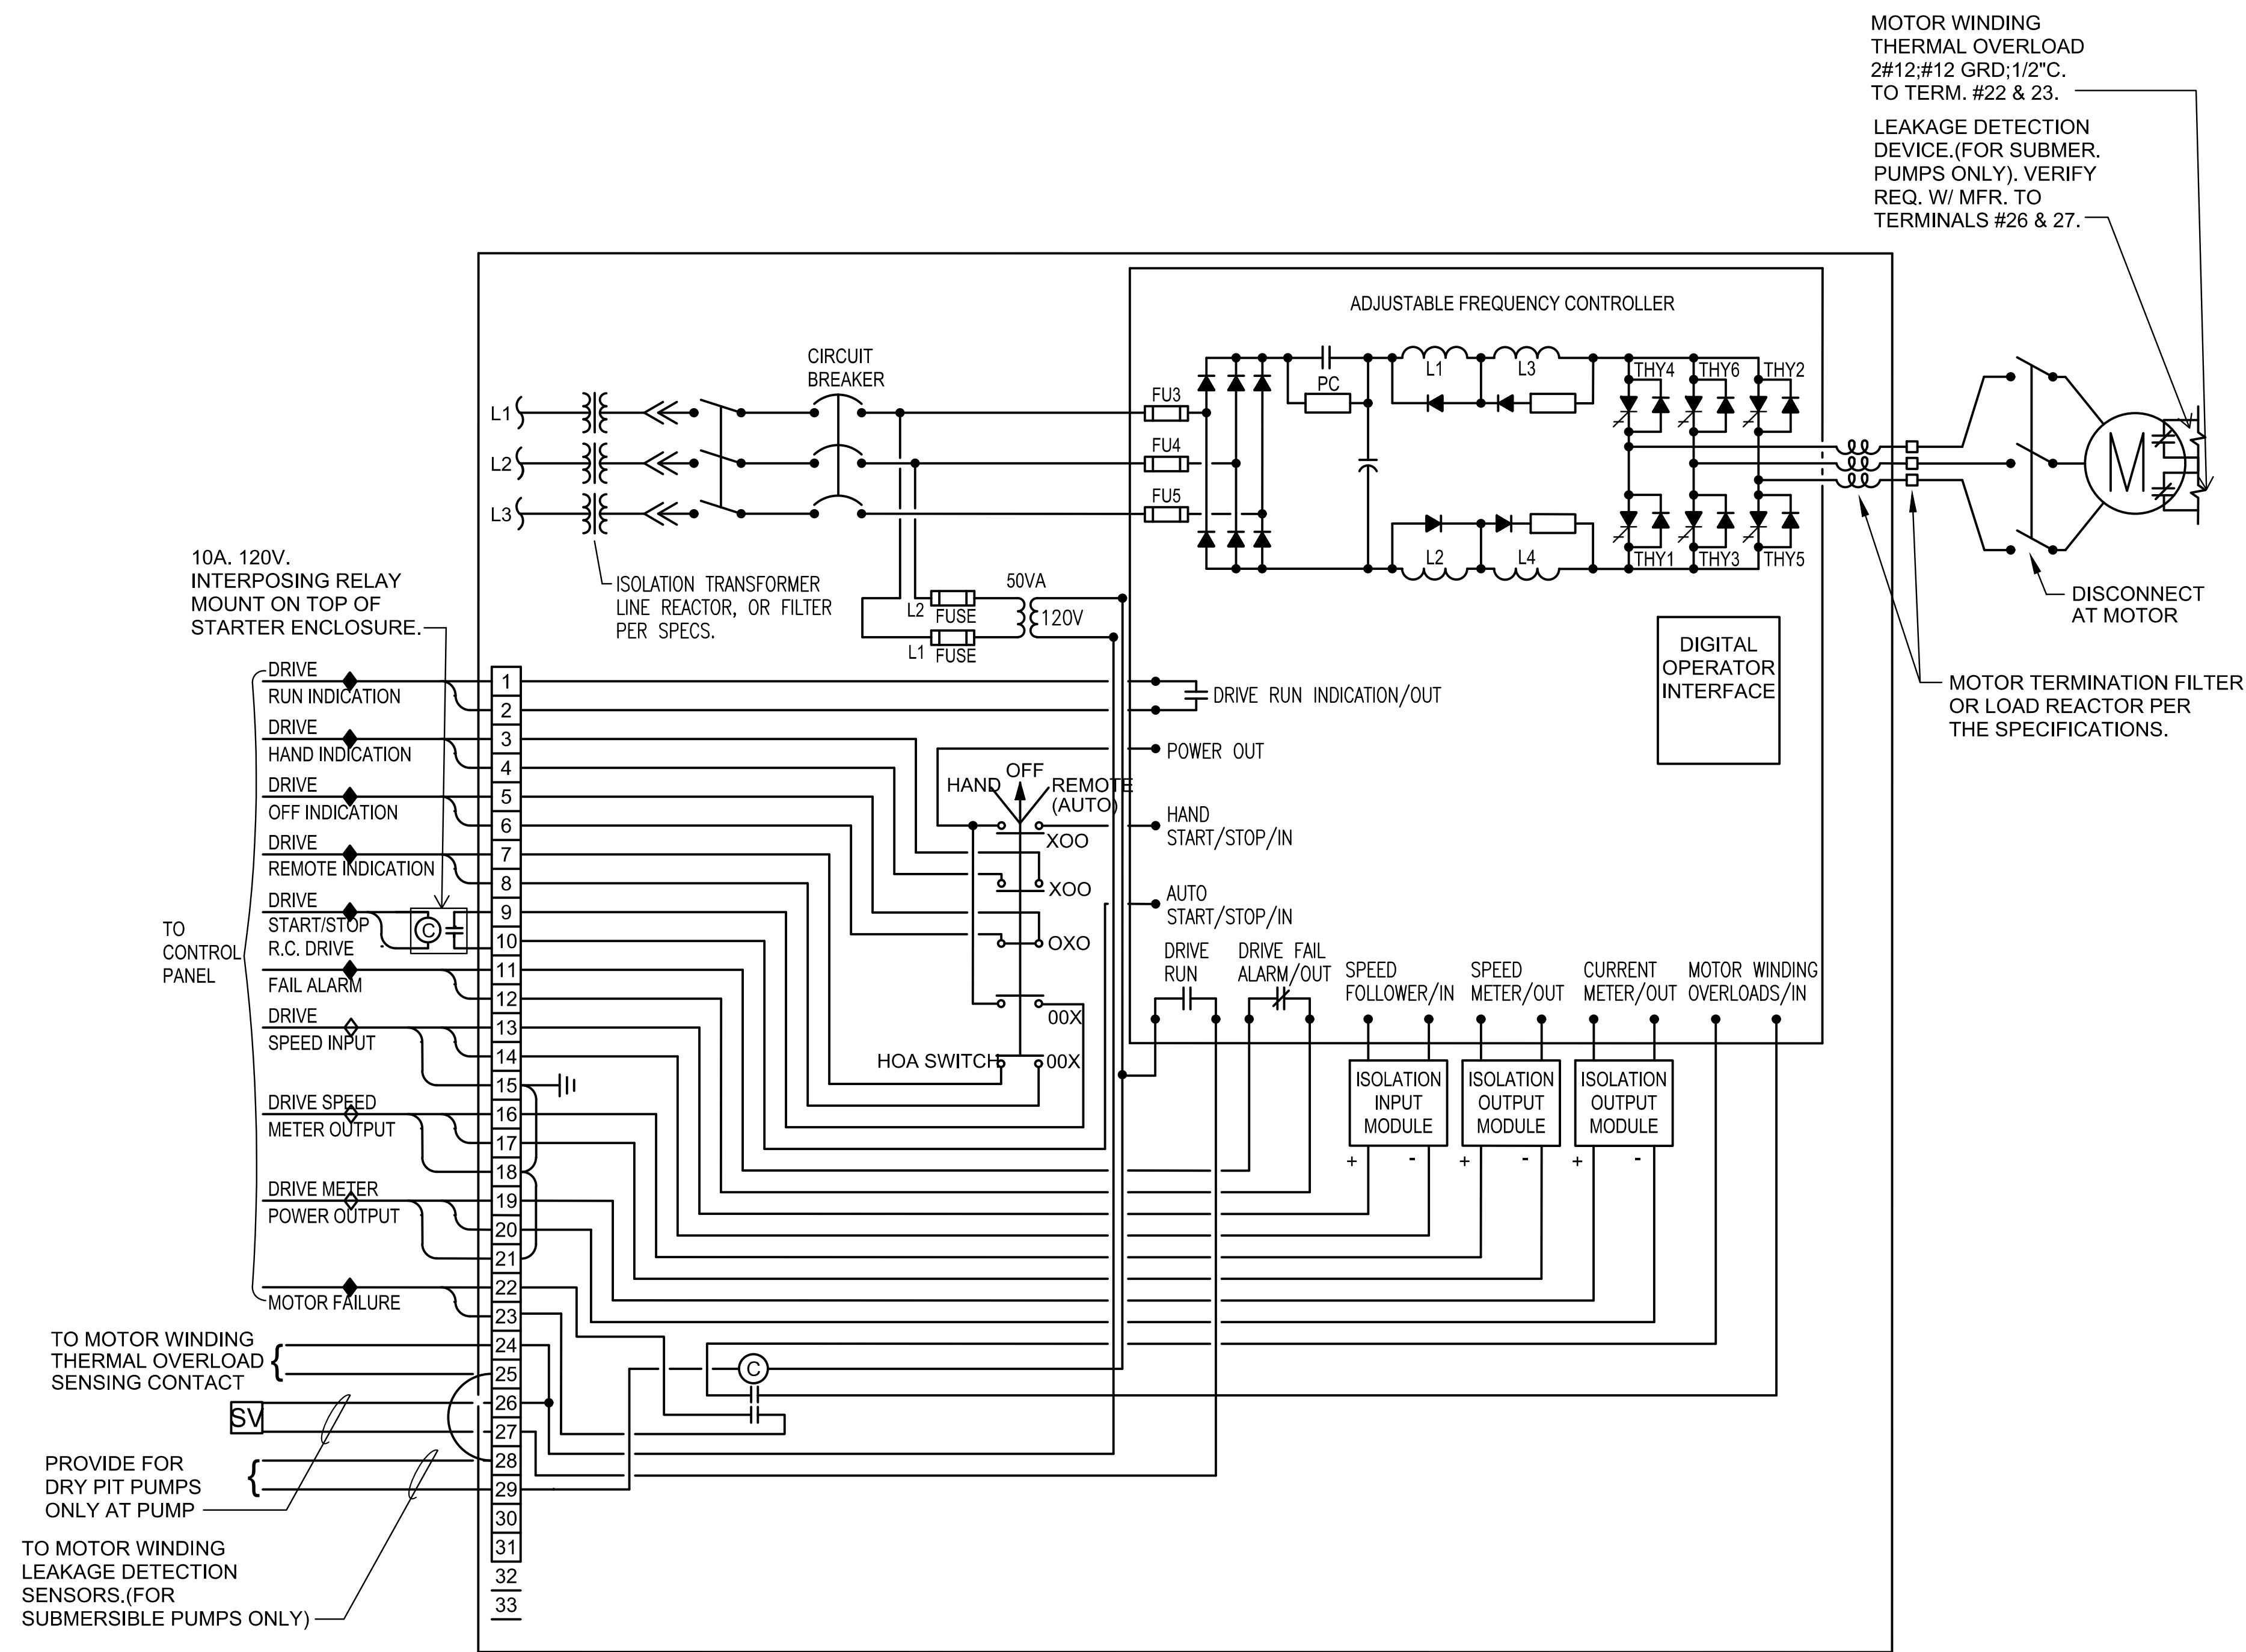
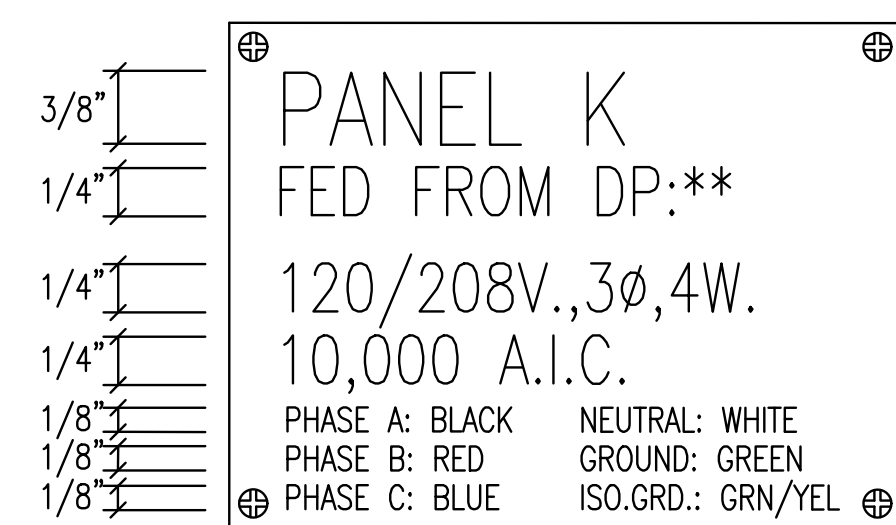


SAVED 12/14/2023 5:17:51 PM BY SEAN GERETY  
 PLOTTED 12/14/2023 5:20:54 PM BY SEAN GERETY  
 U:\WICHITA-CIVIL\2021\210602\002\PECC\DRAWINGS\ELEC\210602-002-E-502.DWG


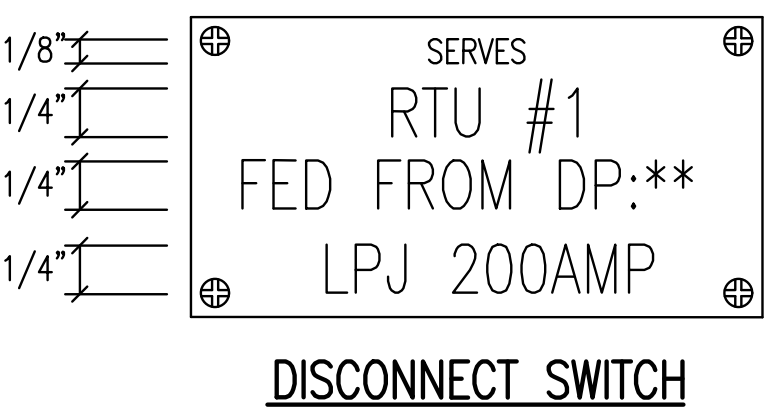


1 TYPICAL VARIABLE FREQUENCY DRIVE WIRING DIAGRAM  
 NO SCALE

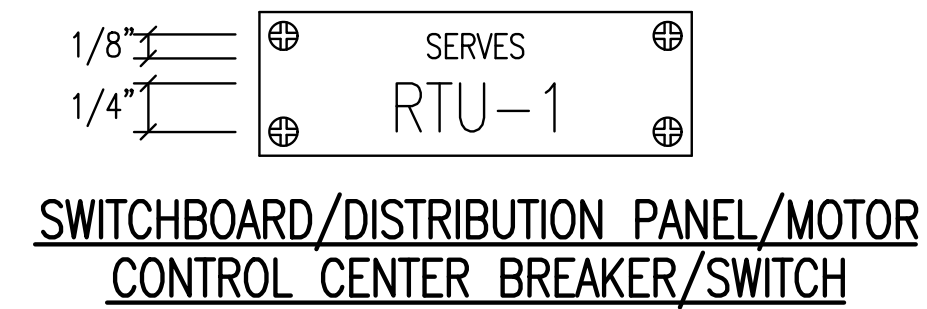

2 TYPICAL NAME PLATES  
 NO SCALE

NOTE: SEE SPECIFICATION SECTION 260500 FOR NAME PLATE COLOR REQUIREMENTS.

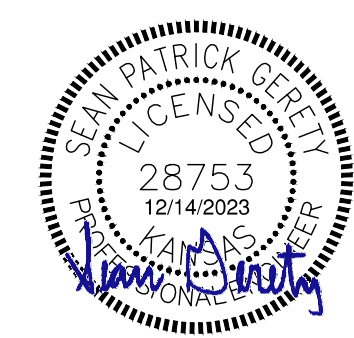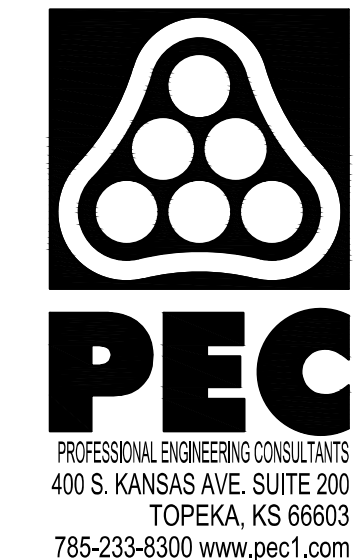

SANITARY SEWER IMPROVEMENTS  
 COWSKIN FORCE MAIN  
 AND LIFT STATION 60  
 IMPROVEMENTS  
 PAUL GUNZELMAN, P.E. - INTERIM CITY ENGINEER  
 CITY OF WICHITA PROJECT NO. 468-2022-040654

Issue:	
JOB NO.	35-210602-001-042
DATE	DECEMBER 2023
PM	TBK
DESIGNED BY	SPG
DRAWN BY	JAB
CHECKED BY	RWW

ELECTRICAL DETAILS

E-502