

NAFTZGER PARK RESTROOM

2024 PARK FACILITY ENHANCEMENTS


ORG CODE: 44003823/ MUNIS: R3008/ ENG: 482-11081

CITY OF WICHITA WICHITA, KANSAS



© 2023 GARVER, LLC
THIS DOCUMENT, ALONG WITH THE IDEAS AND DESIGNS CONVEYED HEREIN, SHALL BE CONSIDERED INSTRUMENTS OF PROFESSIONAL SERVICE AND ARE PROPERTY OF GARVER, LLC. ANY USE, REPRODUCTION, OR DISTRIBUTION OF THIS DOCUMENT, ALONG WITH THE IDEAS AND DESIGN CONTAINED HEREIN, IS PROHIBITED UNLESS AUTHORIZED IN WRITING BY GARVER, LLC OR EXPLICITLY ALLOWED IN THE GOVERNING PROFESSIONAL SERVICES AGREEMENT FOR THIS WORK.

1995 Midfield Road
Wichita, KS 67209
(316) 264-8008

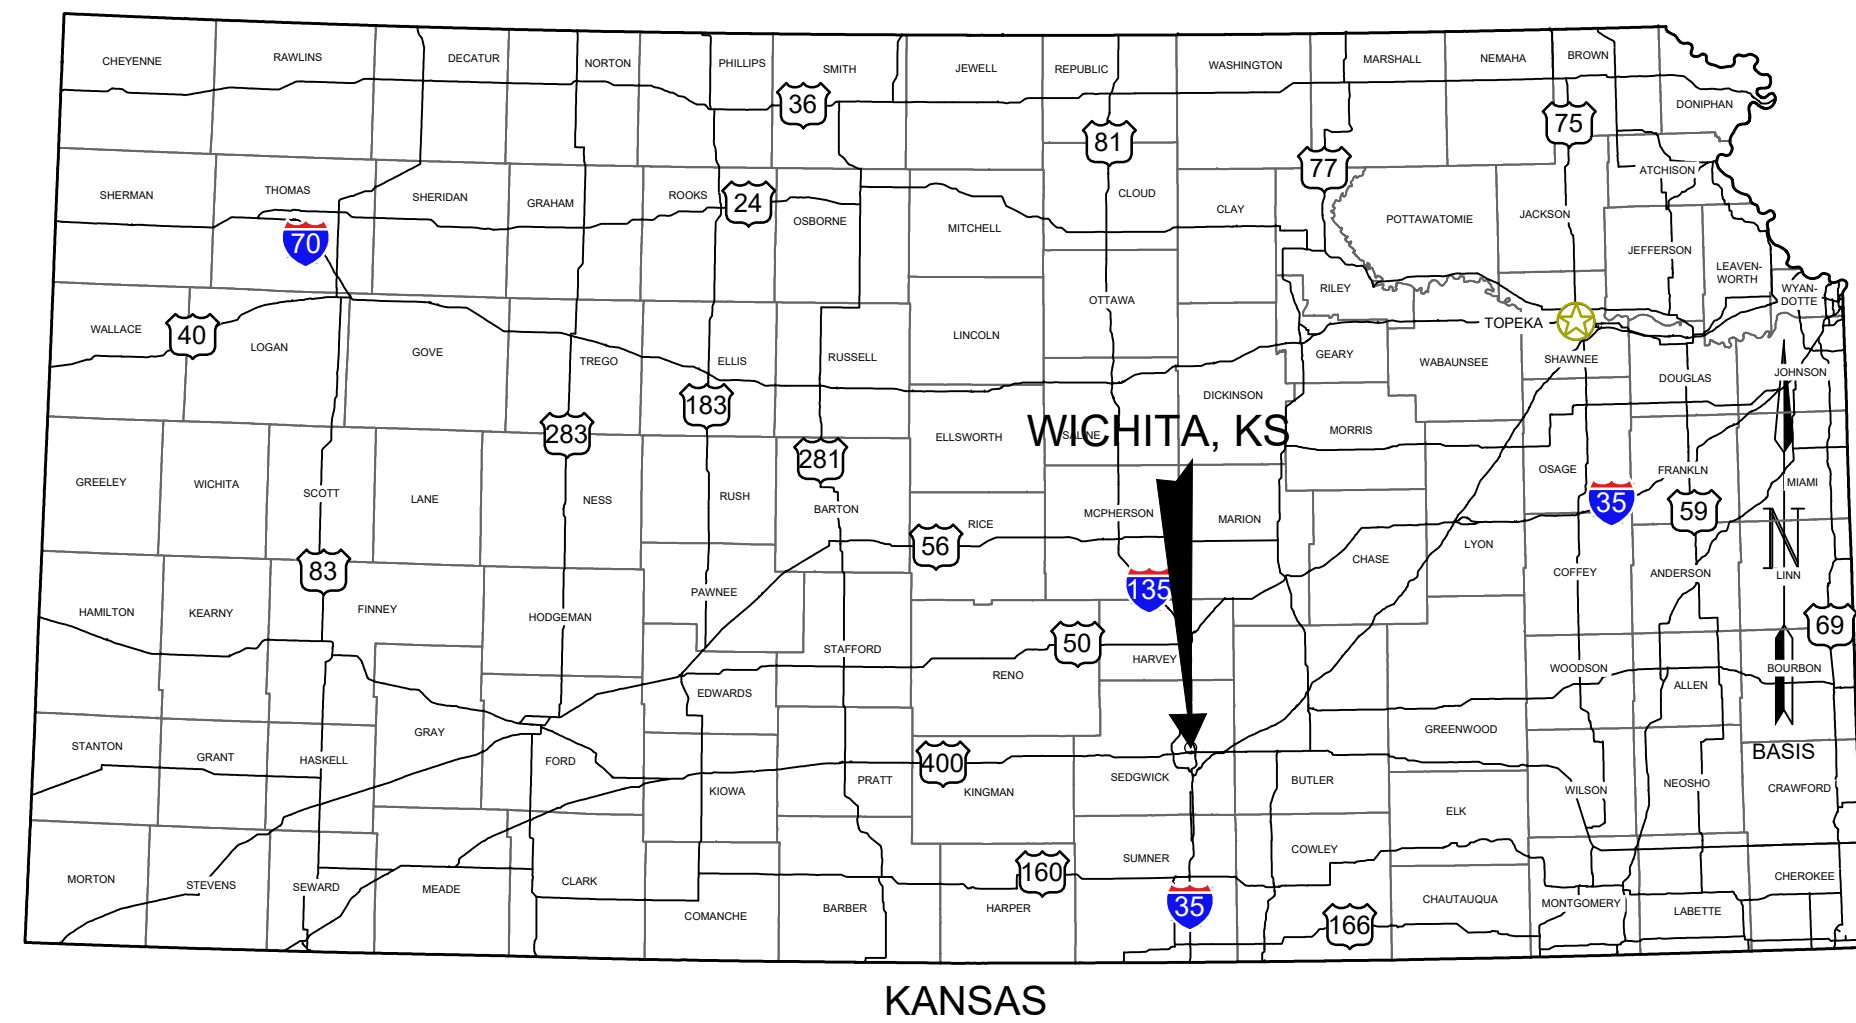

LOCATION MAP



VICINITY MAP
NO SCALE

| SHEET INDEX | |
|-------------|------------------------------------|
| SHEET NO. | TITLE |
| 1 | COVER SHEET |
| 2 | GENERAL NOTES AND SITE ACCESS PLAN |
| 3 | EXISTING CONDITIONS |
| 4 | SITE DEMOLITION PLAN |
| 5 | SITE LAYOUT PLAN |
| 6 | GRADING PLAN |
| 7 | EROSION CONTROL PLAN |
| 8 | UTILITY PLAN |
| 9 | EROSION CONTROL DETAILS 01 |
| 10 | EROSION CONTROL DETAILS 02 |
| 11 | EROSION CONTROL DETAILS 03 |
| 12 | EROSION CONTROL DETAILS 04 |
| 13 | EROSION CONTROL DETAILS 05 |
| 14 | LANDSCAPE PLAN |
| 15 | LANDSCAPE DETAILS 01 |
| 16 | LANDSCAPE DETAILS 02 |
| 17 | ELECTRICAL SITE PLAN |

GARVER PROJECT NO. F02-2301675
FEBRUARY 2024



1995 Midfield Road
Wichita, KS 67209
(316) 264-8008

| REV. | DATE | DESCRIPTION | BY |
|------|------|-------------|----|
| | | | |
| | | | |
| | | | |
| | | | |

CITY OF WICHITA
WICHITA, KS 67202
2024 PARK FACILITY
ENHANCEMENTS-
NAFTZGER PARK
RESTROOMS PROJECT

COVER SHEET

JOB NO.: F02-2301675
DATE: MAR. 2024
DESIGNED BY: ----
DRAWN BY: ----

BAR IS ONE INCH ON ORIGINAL DRAWING
IF NOT ONE INCH ON THIS SHEET, ADJUST SCALES ACCORDINGLY.

DRAWING NUMBER
G001

SHEET NUMBER
1