

A. PRICE WOODARD PARK RESTROOM

2024 PARK FACILITY ENHANCEMENTS

ORG CODE: 44003823/ MUNIS: R3008/ ENG: 482-11081

CITY OF WICHITA

WICHITA, KANSAS

Wichita-Sedgwick County
Metropolitan Area Building
and Construction Department

REVIEWED FOR CODE COMPLIANCE


CORRECTIONS OR COMMENTS MADE ON THESE DRAWINGS AND THIS DOCUMENT DURING THIS REVIEW DO NOT RELIEVE CONTRACTOR FROM COMPLIANCE WITH ALL REQUIREMENTS OF THE CODE OF THE MARCD, THE CITY OF WICHITA OR SEDGWICK COUNTY. THIS REVIEW IS ONLY FOR GENERAL PERFORMANCE OF THE CODE. THE CONTRACTOR IS RESPONSIBLE FOR CONFORMING AND CORRECTING ALL TECHNIQUES OF CONSTRUCTION. THIS APPROVAL IS SUBJECT TO PROVISIONS OF SECTION 197.4 OF THE 2012 INTERNATIONAL BUILDING CODE.

DATE: 07/29/24 BY: William Jerauld Jr



© 2023 GARVER, LLC
THIS DOCUMENT, ALONG WITH THE IDEAS AND DESIGNS CONVEYED HEREIN, SHALL BE CONSIDERED INSTRUMENTS OF PROFESSIONAL SERVICE AND ARE PROPERTY OF GARVER, LLC. ANY USE, REPRODUCTION, OR DISTRIBUTION OF THIS DOCUMENT, ALONG WITH THE IDEAS AND DESIGN CONTAINED HEREIN, IS PROHIBITED UNLESS AUTHORIZED IN WRITING BY GARVER, LLC OR EXPLICITLY ALLOWED IN THE GOVERNING PROFESSIONAL SERVICES AGREEMENT FOR THIS WORK.

1995 Midfield Road
Wichita, KS 67209
(316) 264-8008

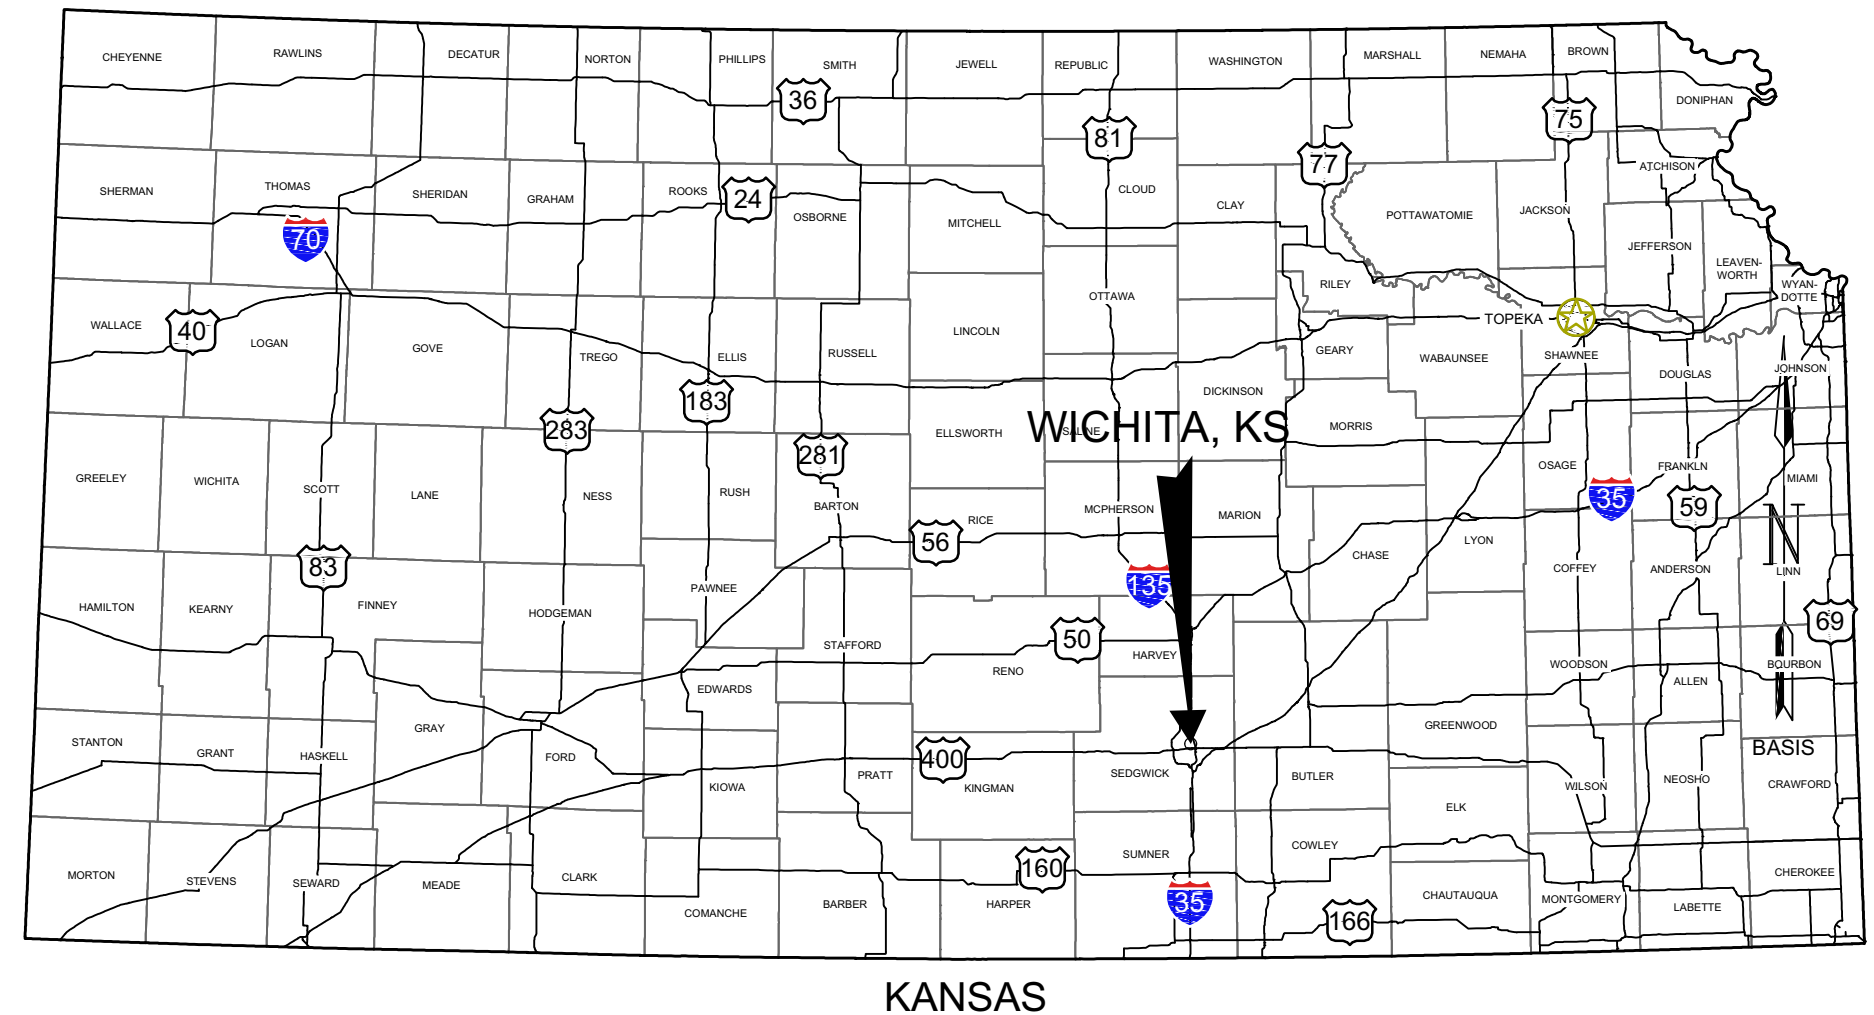

LOCATION MAP



NO SCALE
VICINITY MAP

SHEET INDEX	
SHEET NO.	TITLE
1	COVER SHEET
2	GENERAL NOTES AND SITE ACCESS PLAN
3	EXISTING CONDITIONS
4	SITE DEMOLITION PLAN
5	SITE LAYOUT PLAN
6	GRADING PLAN
7	EROSION CONTROL PLAN
8	UTILITY PLAN
9	EROSION CONTROL DETAILS 01
10	EROSION CONTROL DETAILS 02
11	EROSION CONTROL DETAILS 03
12	EROSION CONTROL DETAILS 04
13	EROSION CONTROL DETAILS 05
14	ELECTRICAL SITE PLAN

GARVER PROJECT NO. F02-2301675
FEBRUARY 2024



1995 Midfield Road
Wichita, KS 67209
(316) 264-8008

REV.	DATE	DESCRIPTION	BY

CITY OF WICHITA
DEPT. OF PARKS AND RECREATION
WICHITA, KS 67202

2024 PARK FACILITY
ENHANCEMENTS -
A. PRICE WOODARD
RESTROOMS PROJECT

COVER

JOB NO.: F02-2301675
DATE: FEB. 2024
DESIGNED BY: SRS
DRAWN BY: CJW

BAR IS ONE INCH ON ORIGINAL DRAWING
IF NOT ONE INCH ON THIS SHEET, ADJUST SCALES ACCORDINGLY.

DRAWING NUMBER
G001

SHEET NUMBER
1

File: L:\2023\F02-2301675 - Wichita Downtown Park Restrooms\Drawings\CAD_BIM_Sheets\A_Price Woodard\WDRA_G001_CO.dwg Last Save: 5/20/2024 2:58 PM Last saved by: C.Wyant
Last Plotted by: Wyant, Charles J. (CJ) Plot Style: AECmono-CT.ctb Plot Scale: 1:1 Plot Date: 5/20/2024 3:07 PM Plotter used: DWG To PDF.pc3